
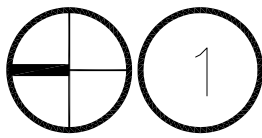



SHEET NOTES

- ① EXISTING RISER POLE AND ELECTRICAL METER.
- ⑨ PROVIDE TWO (2) 1" C WITH PULL WIRE FROM PTM KIOSK PROVIDED RACEWAYS TO PROPERTY LINE ADJACENT TO BASE OF EXISTING TELEPHONE PEDESTAL LOCATION FOR TELEPHONE AND SECURITY SERVICE. MARK LOCATION AT TELEPHONE PEDESTAL. TURN TELEPHONE AND SECURITY CONDUITS THROUGH BACK WALL OF PTM KIOSK UP INTO PROVIDED RACEWAYS.
- ⑫ EXISTING TELEPHONE PEDESTAL.

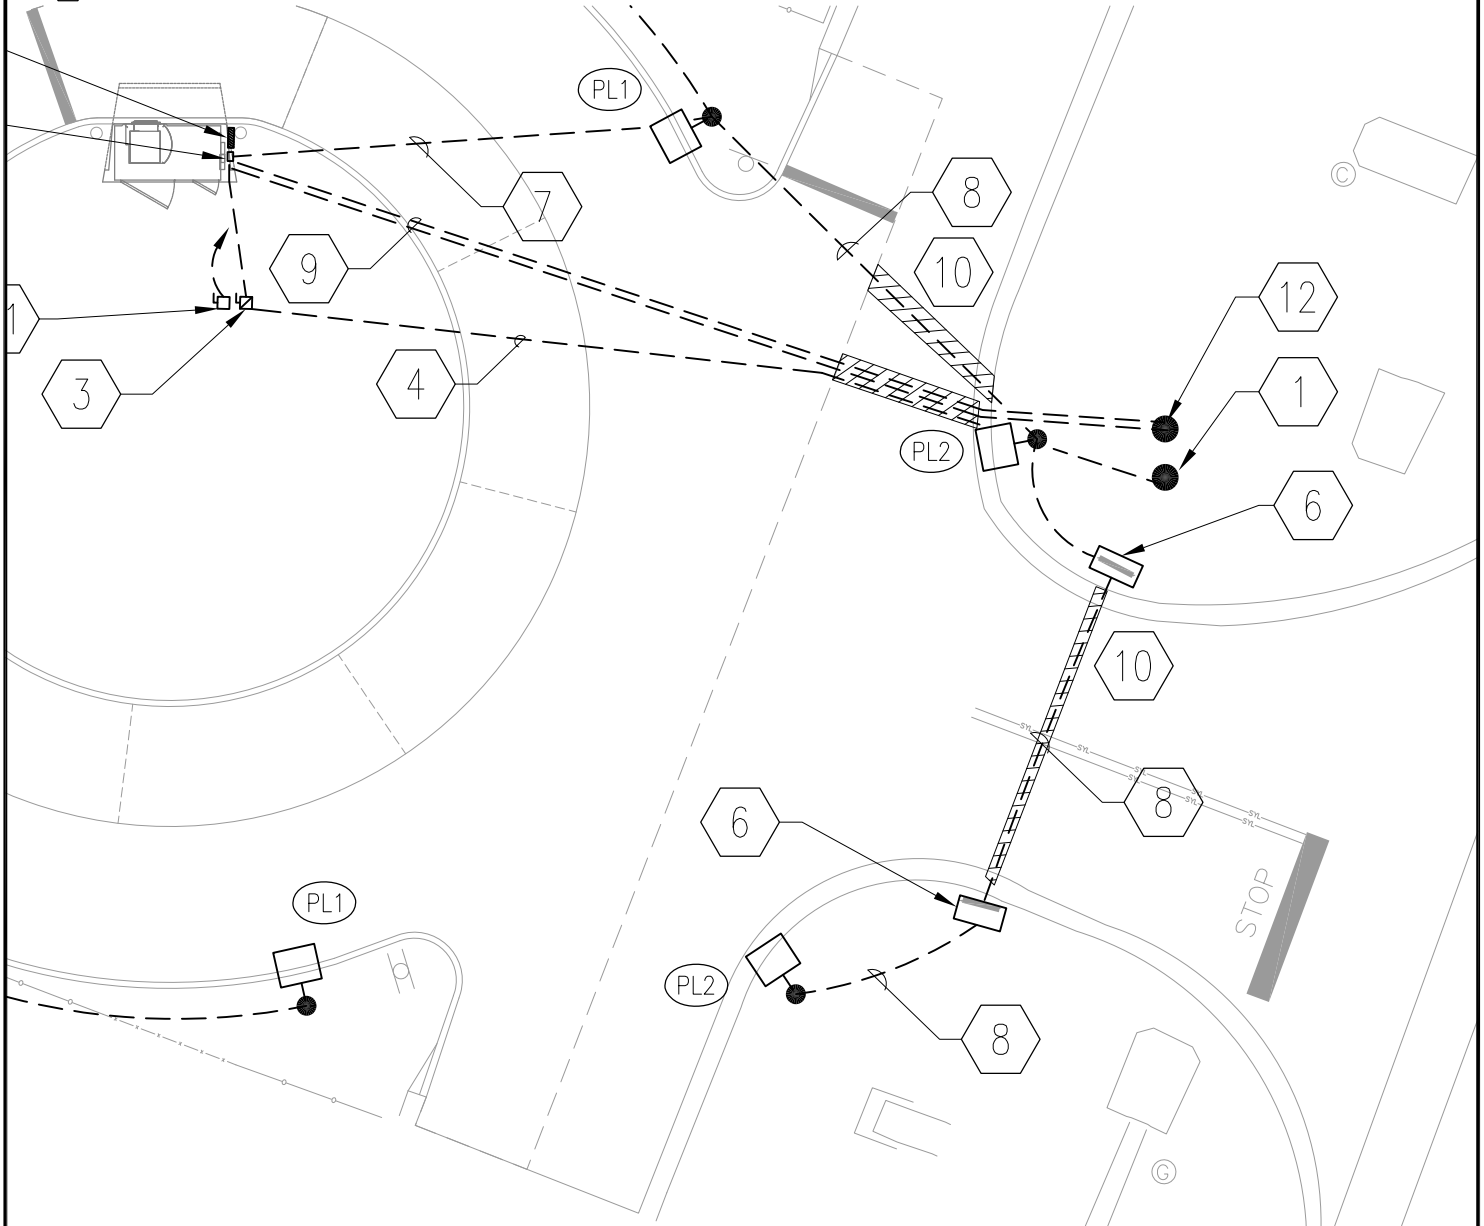

ELECTRICAL SITE PLAN

 16' 0' 16' 32'



SCALE: 1/16" = 1'-0"



MECHANICAL • ELECTRICAL • STRUCTURAL
 COMMUNICATIONS • INDUSTRIAL
 FLORIDA LICENSE • NUMBER 05371
 901 W. GARDEN ST. • PENSACOLA, FL 32502
 P: 850-438-0050 • F: 850-432-8631
 TODD NICHOLSON P.E.
 FLORIDA LICENSE NUMBER 56882
 SCG PROJECT: 2016-119

**PENAIR FEDERAL
 CREDIT UNION**

5639 WOODBINE ROAD
 PACE, FLORIDA

DATE	MAY 10 2016	2016-119
DESIGNED	JTH	ESK-1
DRAWN	JTH	
APPROVED	TAN	SHEET 1 OF 1